

## REQUEST FOR PROPOSALS

### Removal/Replacement of Diesel Fuel Storage Tanks


DULUTH TRANSIT AUTHORITY

## Addendum #2

June 1, 2020

1. Note, rough drawings of the location and type of tanks from the original building construction are attached. The DTA makes no representation as to the accuracy of the drawings, they are for informational purposes only.

2. The preproposal meeting scheduled for Tuesday, June 2, 2020 at 10:00 a.m. is not mandatory. A conference number is available for interested parties to participate in the preproposal meeting; please contact [nbrown@duluthtransit.com](mailto:nbrown@duluthtransit.com) for phone participation arrangements. Visitors are required to wear a mask while in DTA facilities.

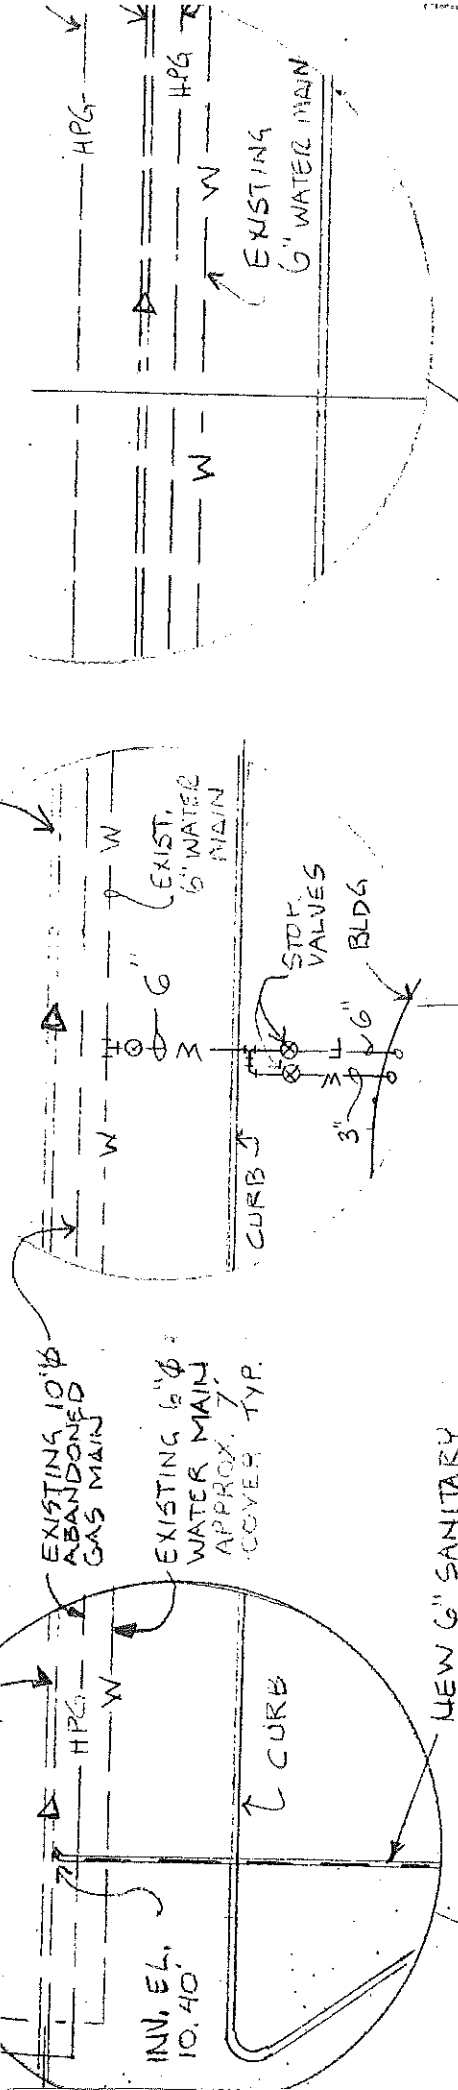

NEW 6" WATER SERVICE TO BLDG. SPLIT INTO 3" DOMESTIC WATER AND 6" FIRE LINE BEFORE ENTERING BLDG.

MICHIGAN STREET

HYDRANT

NEW 6" SANITARY SEWER LINE - CONNECT TO CITY MAIN IN STREET.

NEW INTERRUPTIBLE GAS LINE - CONNECT TO CITY MAIN

1/2" FOS, 1/2" FOR 3/4" FOG  
FOS # FOR TO BE ENCASED IN 3" SCH 80 STEEL PIPE  
FOS TO BE ENCASED IN 1 1/2" SCH 80 STEEL PIPE

ALT. 4A

EXISTING 30" STORM SEWER LINE (UNDER BLDG.)

1/2" FOS, 1/2" FOR 3/4" FOG  
ALL ENCASED IN 1 1/2" SCH 80 STEEL PIPE

ALT. 4B

EXISTING MILLER CREEK CULVERT (UNDER BUILDING)

20000 GALLON BOILER F.O. STORAGE TANK  
ALT. 4A (MS)

BUS FUEL STORAGE TANKS (BY GEN'L CONTR.)

1000 GAL. ST. ALT. 4 B

PARKING LOT


PARKING LOT

BOLLARDS


NEW 6" FIRE SUPPLY LINE - MAINTAIN 7 FT.

BOLLARDS  
NEW FIRE HYDRANT  
NEW FIRE HYDRANT SHUTOFF VALVE - 6"  
NEW 6" SHUTOFF VALVE

PROPERTY

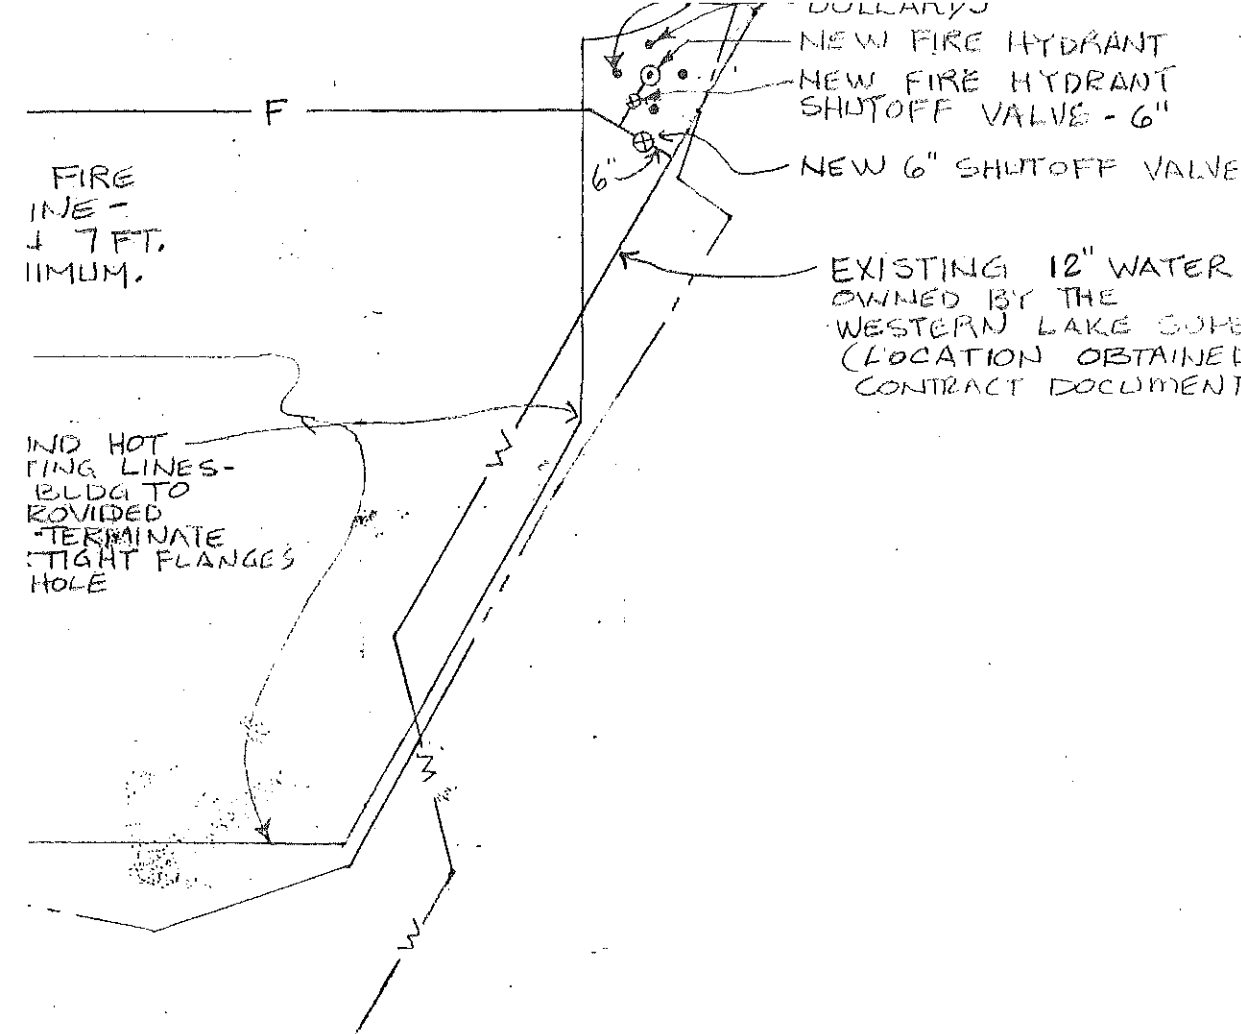

3" TAPPINGS FOR F.O. SUP, RET, GAUGE

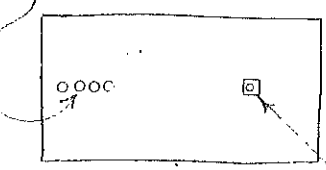


1,000 GAL STORAGE TANK ALT # 4B

EXISTING 12" WATER LINE OWNED BY THE WESTERN LAKE SUPERIOR SANITARY DISTRICT (LOCATION OBTAINED FROM CONSOER-TOWNSH. 10 & ASSOCIATES CONTRACT DOCUMENTS FOR WLSSD PROJECT NO. 15-3).

FIRE INJE - 7 FT. MINUM.

IND HOT PING LINES - BLDG TO PROVIDED - TERMINATE TIGHT FLANGES HOLE


3" VENT LINE - RUN STRAIGHT UP - TERMINATE 2 FT. ABOVE GRADE (EARTH BERM ABOVE)  
3" TAPPINGS FOR F.O. SUP, RET, GAUGE

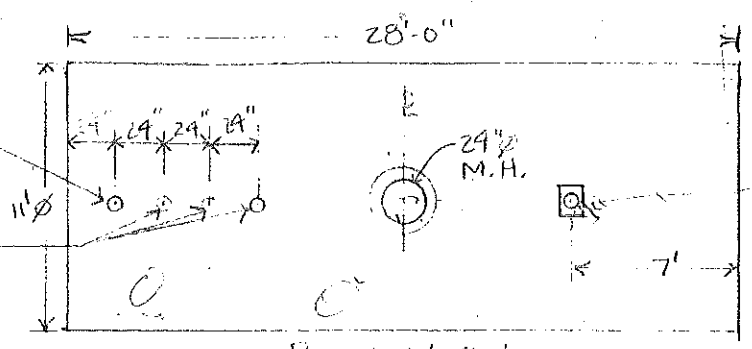

4" FILL UP TO PARKING LOT SURFACE - W/ TRAFFIC DUTY LOCKING COVER - POUR 12" x 12" x 4" CONCRETE PAD FLUSH W/ SURFACE.

PLAN VIEW

SITE PLAN  
SCALE: 1" = 40'-0"

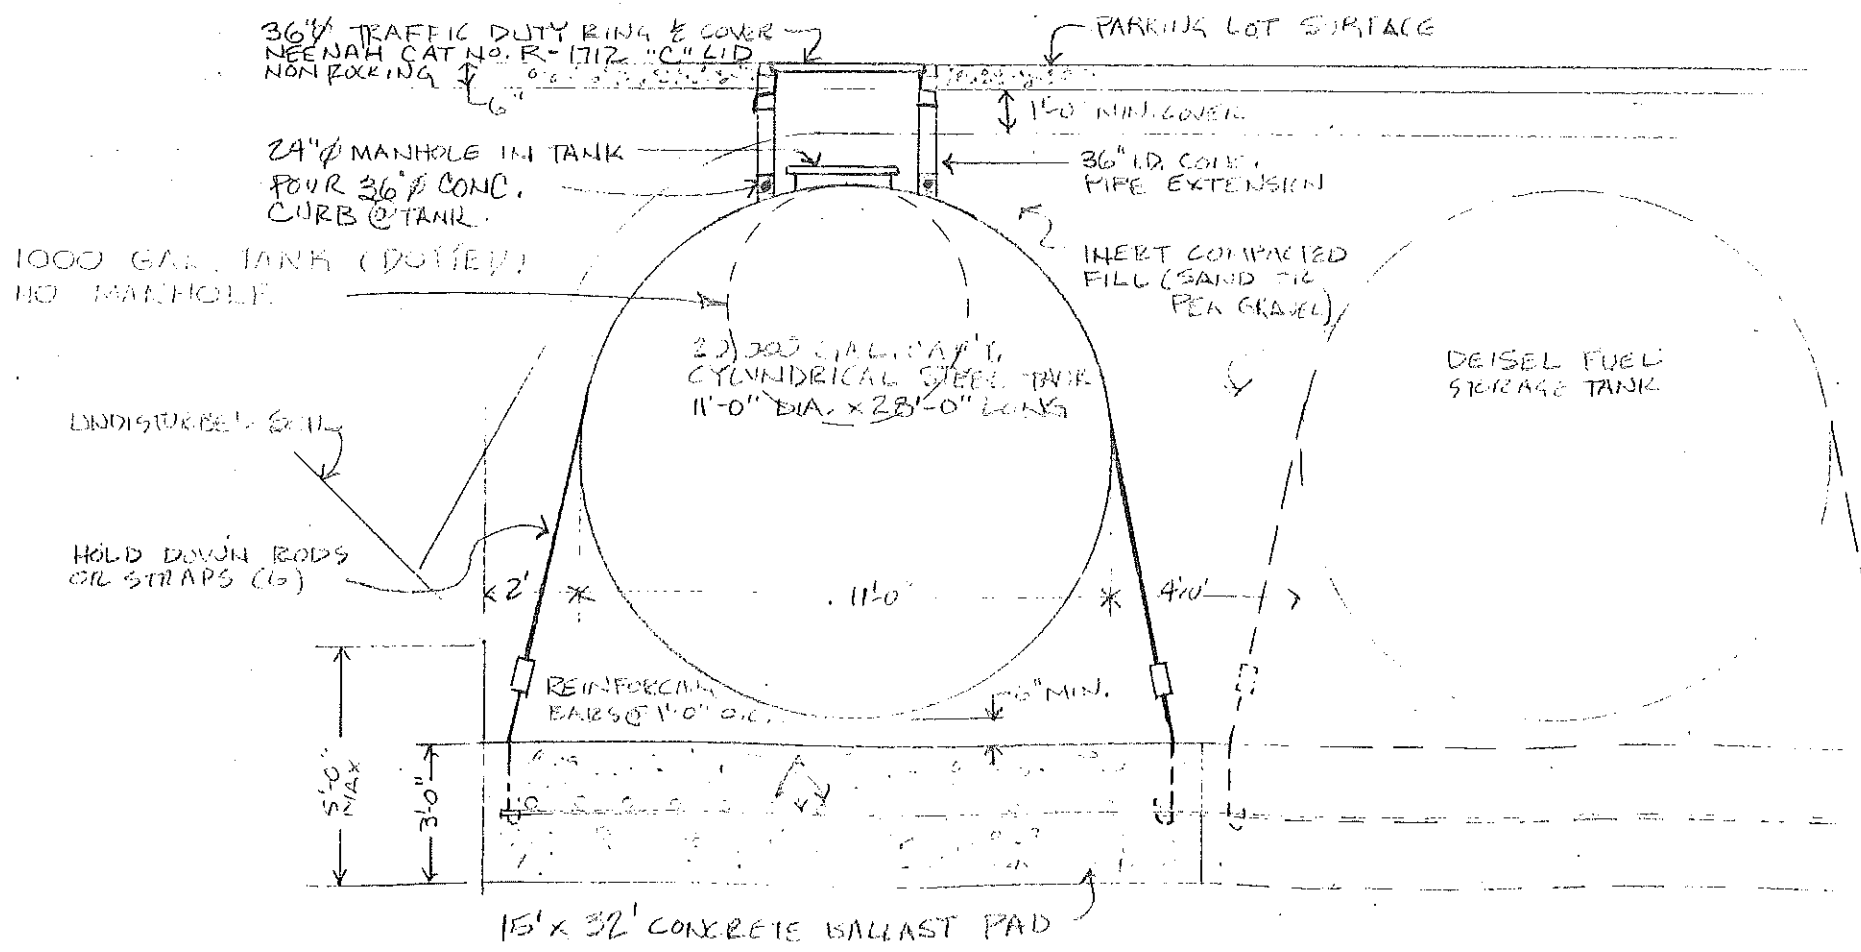

1/M3 UNDERGROUND FUEL OIL STORAGE TANK